


# OPTION:-01

ROOF HT. 12'-0"

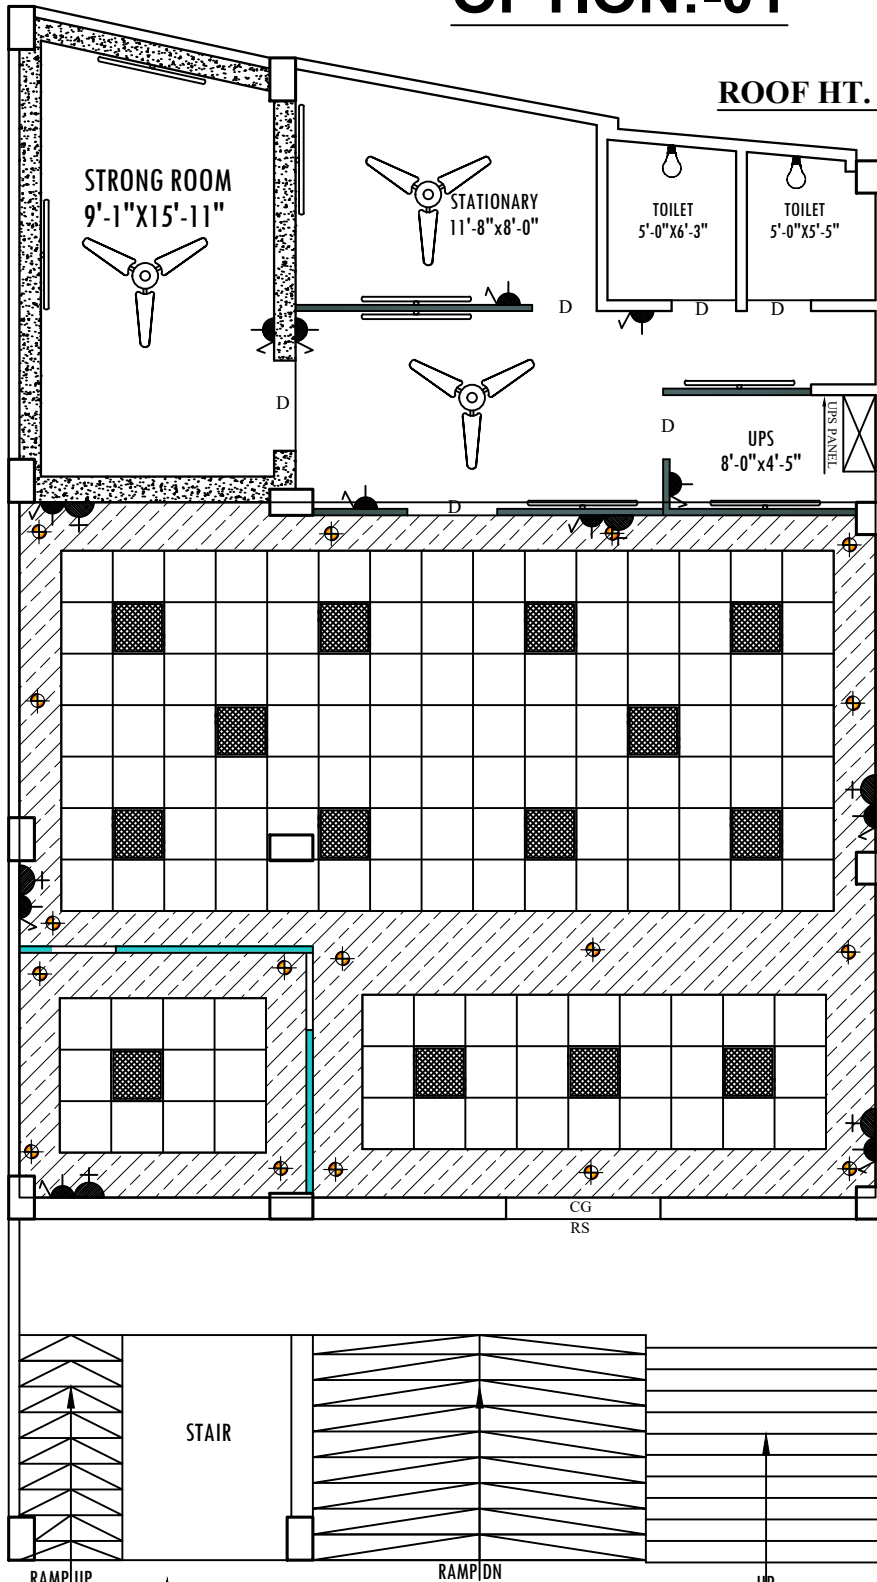

TOTAL CARPET BRANCH  
AREA = 1305.00 sq.ft.(Approximate)

R O A D

GROUND FLOOR PLAN

Note :-

- \* This drawing is property of **FVC** it must not be retained, copied reproduced in any form without written permission of **FVC**.
- \* Use architectural drawing for detail dimensions.
- \* In case of any discrepancy in this drawing or difficulty at site this office should be referred.
- \* Position of power and light points should be compared with the position of geyser and basin from p.h.e. drawing.
- \* Diameter of sub main conduit is 1" and remaining are of 0.75".

## LEGEND

| SYMBOL | DESCRIPTION                           | HEIGHT    |
|--------|---------------------------------------|-----------|
|        | CEILING FAN                           | CEILING   |
|        | 1X4'-40W FLUORESCENT FIXTURE          | 7'-0"     |
|        | WALL BRACKET/CFL                      | 7'-0"     |
|        | CEILING LIGHT                         | CEILING   |
|        | CHANDELIER                            | CEILING   |
|        | SWITCH BOARD WITH 5 AMP SOCKET        | 4'-6"     |
|        | SWITCH BOARD                          | 4'-6"     |
|        | 5 PIN 5A PLUG WITH SWITCH             | 1'6"/5'6" |
|        | 5 PIN 15A POWER PLUG                  | 1'6"/4'6" |
|        | F/M FOR FREEZE & W/M FOR WASHING      | 1'6"/4'6" |
|        | 25A A.C. POWER PLUG                   | 1'6"      |
|        | CALL BELL PUSH SWITCH                 | 4'6"      |
|        | CALL BELL BUZZER                      | 7'-0"     |
|        | EXHAUST FAN                           | 7'-0"     |
|        | T.V. OUTLET                           | 1'6"      |
|        | TELEPHONE OUTLET                      | 1'6"      |
|        | FIRE DETECTION SYSTEM                 |           |
|        | DISTRIBUTION BOX                      | 6' 0"     |
|        | T.V. JUNCTION BOX                     |           |
|        | JUNCTION BOX                          |           |
|        | L.T. MAIN CONTROL PANEL               |           |
|        | WAY FOR T.V. & TELEPHONE WIRING.      |           |
|        | WAY FOR POINT WIRING. (25mm dia pipe) |           |
|        | WAY FOR POINT WIRING (19mm dia pipe)  |           |
|        | WAY FOR SUB MAIN WIRING.              |           |
|        | WAY FOR POWER POINT WIRING.           |           |
|        | WAY FOR CIRCUIT WIRING.               |           |

PROJECT

PROPOSED INTERIOR LAYOUT OF  
**CENTRAL BANK INDIA**

**AT- MIRGANJ BRANCH**

CLIENT

**CENTRAL BANK OF INDIA**

DRAWN BY

RAHUL SINGH

NORTH

CHECKED BY

SCALE

NOT TO SCALE

DATE

05-04-2024

REVISION

SHEET TITLE

(ID-01)

DRAWING TITLE

**ELECTRICAL LAYOUT PLAN -01**

Architects :-



**ARTCON DESIGN CONSULTANTS**  
ARCHITECTS, ENGINEERS  
INTERIOR DESIGNERS, COMPUTER AIDED DESIGN  
G-04 Laxmi Palace, Mitra Compound, Boring  
Road, Patna - 800001  
+91 9937237771, email: artcon73@gmail.com  
+91 9386171726, artcondesignconsultants.com